



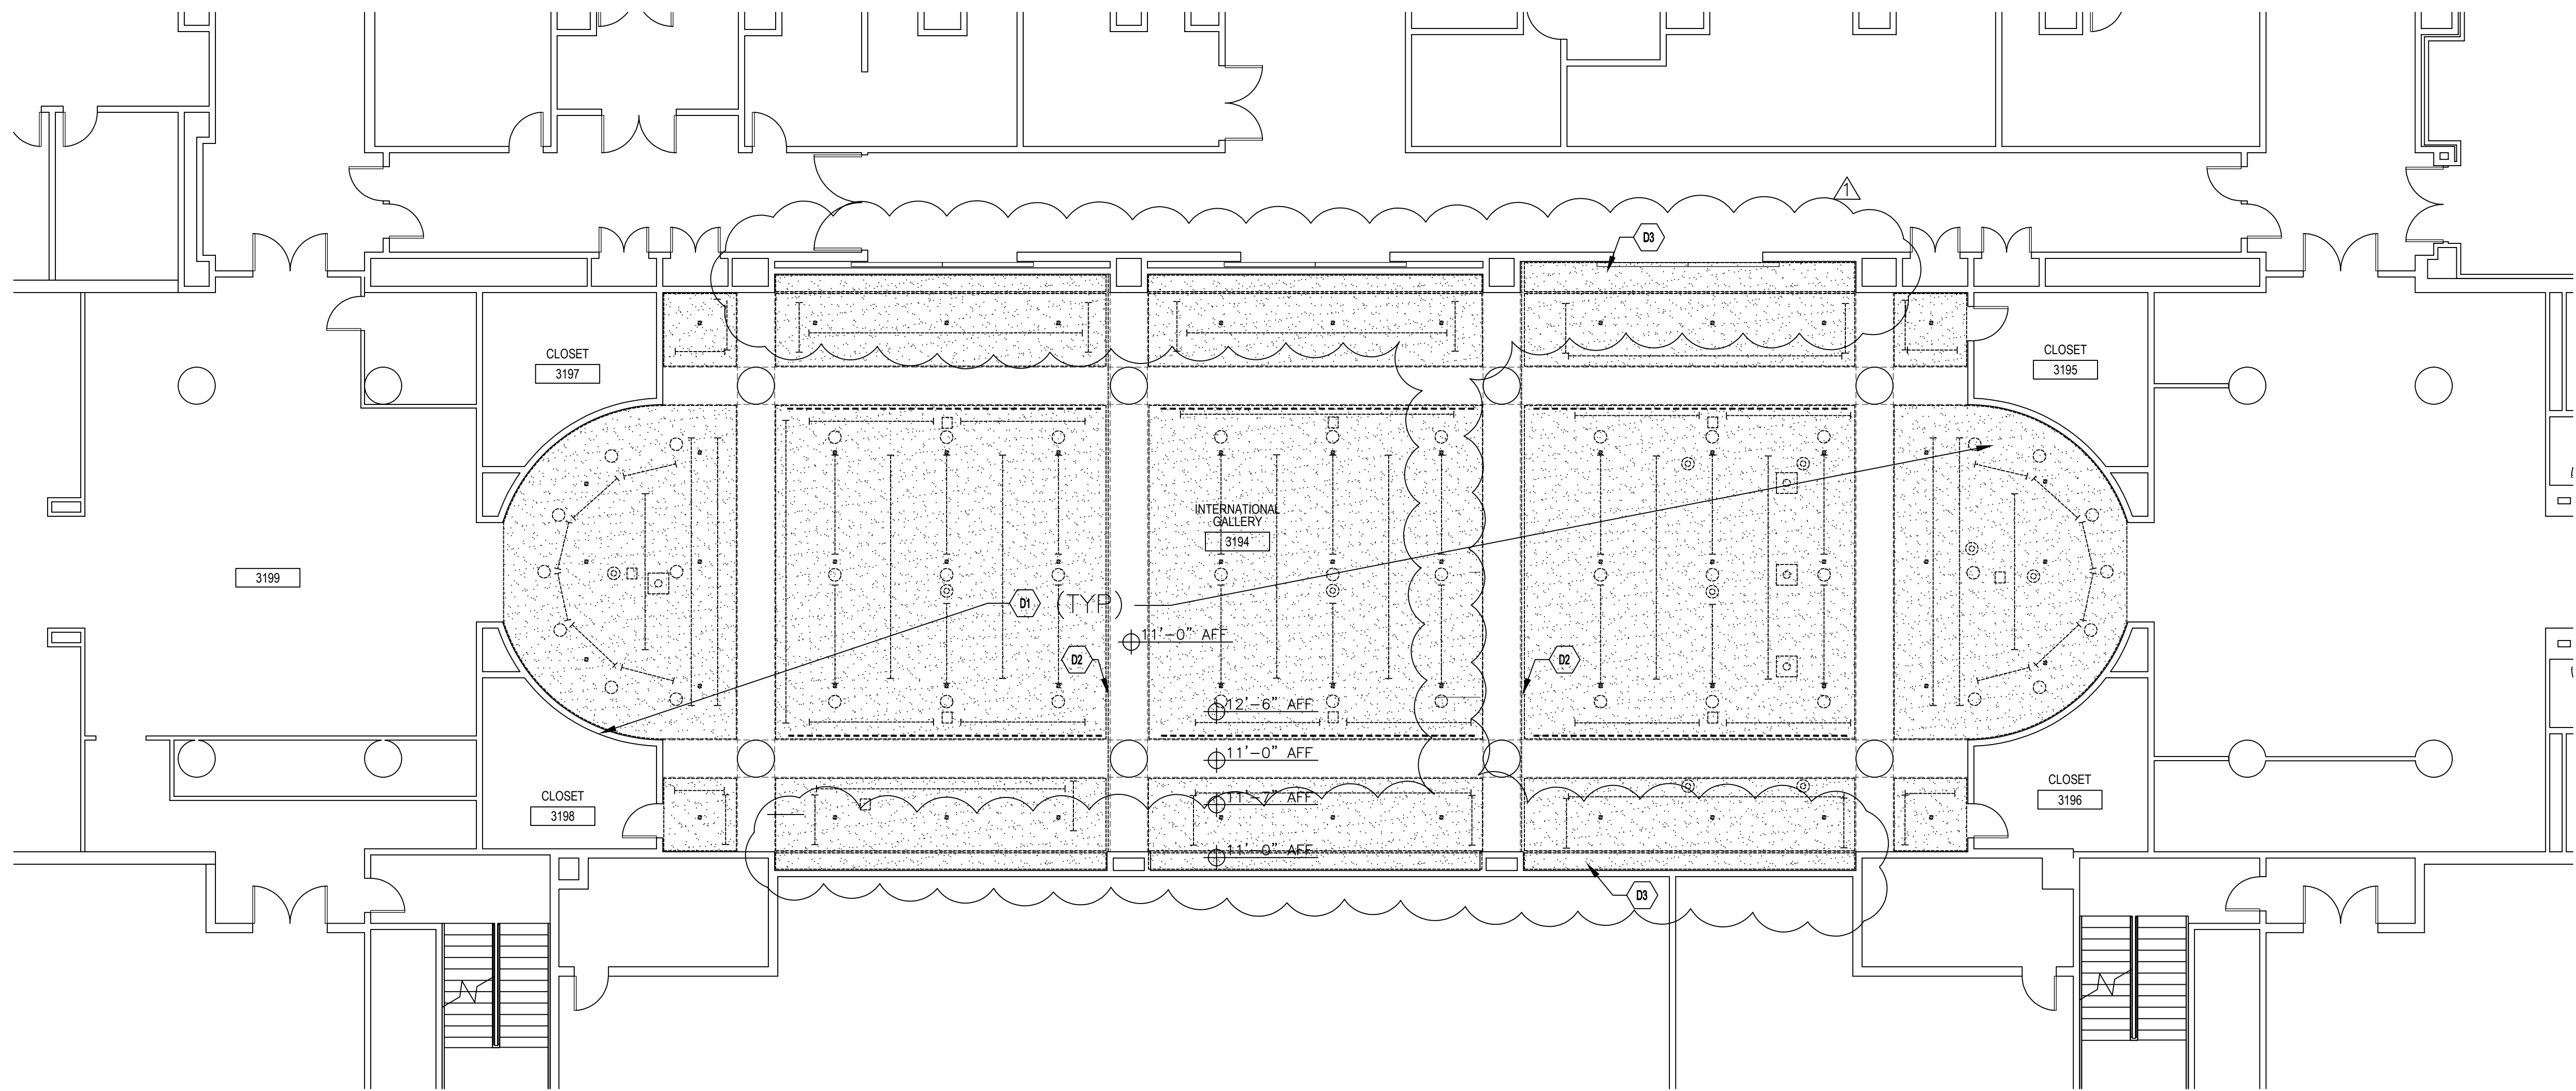

1
A-101
REFLECTED CEILING PLAN LEVEL 3 - DEMOLITION
1/8" = 1' - 0"

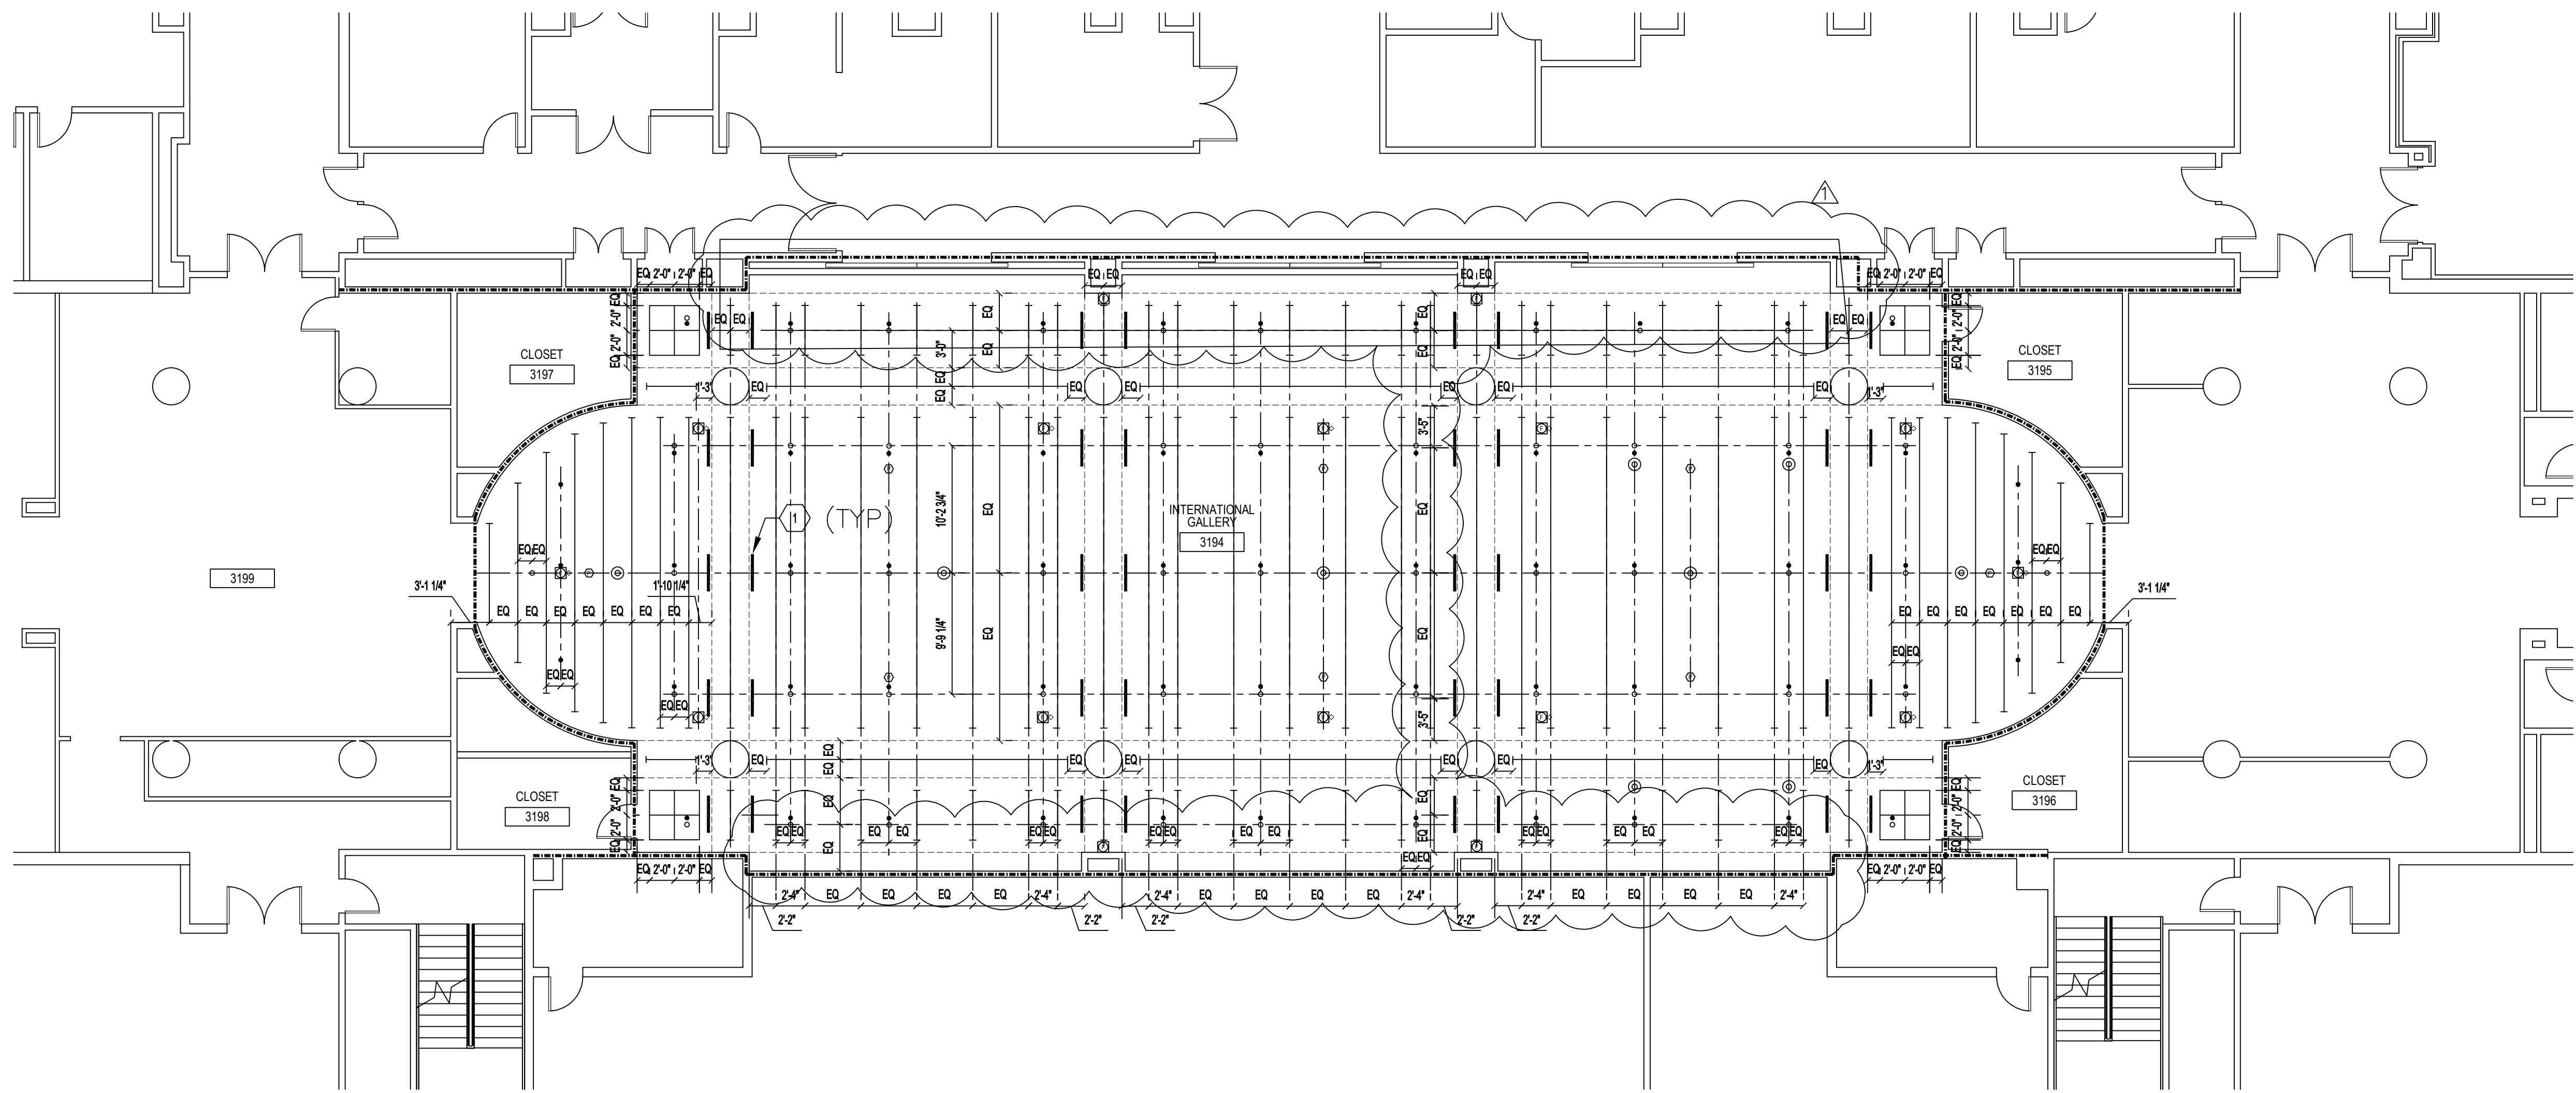

2
A-101
REFLECTED CEILING PLAN LEVEL 3 - NEW WORK
1/8" = 1' - 0"

GENERAL NOTES

- NEW CEILING SHALL MATCH EXISTING CEILING HEIGHTS AFF.
- CONTRACTOR TO SURVEY ALL ABOVE CEILING AREAS FOR EXISTING CONDITIONS.
- FOR NEW LIGHTING, REFER TO LIGHTING DOCUMENTS.
- FOR NEW ELECTRICAL, REFER TO ELECTRICAL DOCUMENTS.
- FOR NEW MECHANICAL, REFER TO MECHANICAL DOCUMENTS.
- FOR NEW FIRE PROTECTION, REFER TO FIRE PROTECTION DOCUMENTS.
- CEILING PAINT TO BE BENJAMIN MOORE OC-145 'TRIUM WHITE'.

DEMO KEYNOTES

- D1. REMOVE EXISTING DRYWALL CEILING, CEILING SUPPORT, SPRINKLER HEADS, EXISTING LIGHTING TRACK, EXISTING SMOKE DETECTORS, EXISTING DOWNLIGHTS, EXISTING SPEAKERS.
- D2. EXISTING PARTITION, DOOR AND FRAME TO REMAIN.
- D3. WHERE EXISTING CEILING SOFFITS ARE NOT TO RECEIVE ANY MODIFICATIONS (DIFFUSERS, LIGHTING, SPRINKLERS, DETECTORS, ETC.), EXISTING CAN REMAIN TO RECEIVE A NEW LEVEL 5 FINISH TO MATCH NEW CEILING.

DEMO LEGEND


- (X) INDICATES KEY NOTE ON THIS DRAWING.
- DEMOLITION WORK
- EXISTING WALL CONSTRUCTION TO REMAIN
- EXISTING SPRINKLER HEAD TO BE REMOVED
- EXISTING GYP CLG TO BE REMOVED
- EXISTING SPEAKER TO BE REMOVED
- EXISTING SMOKE DETECTOR TO BE REMOVED
- EXISTING DOWNLIGHT TO BE REMOVED
- EXISTING TRACK LIGHT TO BE REMOVED
- EXISTING CEILING MOUNTED PROJECTOR TO BE REMOVED

KEYNOTES

1. PROVIDE ACCESS PANELS, SEE DETAIL 8/A-501

NEW WORK LEGEND


- (X) INDICATES KEY NOTE ON THIS DRAWING.
- CENTERLINE
- EXISTING WALL CONSTRUCTION TO REMAIN
- CONCEALED SPRINKLER HEAD. SEE FP DWGS.
- GYP CLG, MATCH EXISTING CLG HEIGHTS.
- EXISTING SPEAKER TO BE PAINTED & REINSTALLED
- FIRE ALARM DEVICE, SEE FA DWGS
- DOWNLIGHT, SEE ELEC DWGS.
- TRACK LIGHT, SEE ELEC DWGS.
- SOFFIT ACCESS PANEL LOCATION
- SMOKE DETECTOR, SEE FA DWGS.
- EXISTING RATED PARTITION TO REMAIN. MAINTAIN RATINGS WITH NEW WORK, NEW PENETRATIONS.

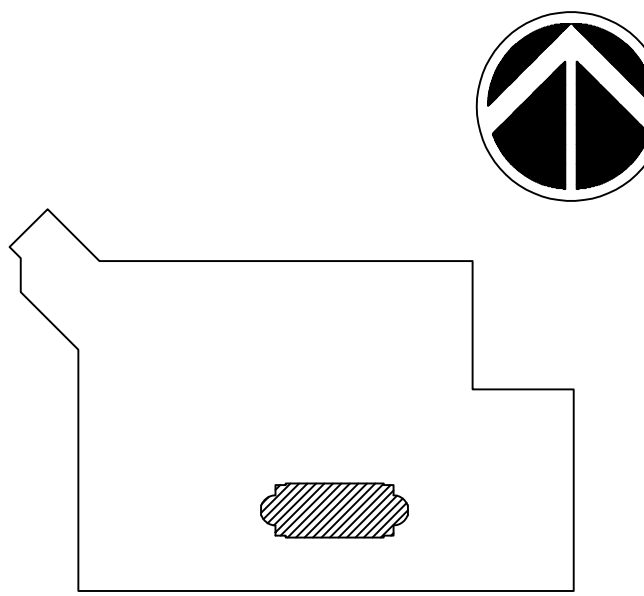

KEY PLAN

GRAPHIC SCALE(S)

DATE	SUBMISSION
11/01/24	100% CD
REVISION	REVISION
11/20/26	BID ADDENDUM A
REVISION 2	
REVISION 3	
REVISION 4	
REVISION 5	
REVISION 6	
REVISION 7	

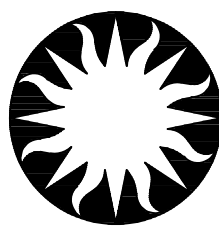

Smithsonian
Institution

Smithsonian Facilities
600 Maryland Avenue S.W. Suite 5001
Washington, DC 20560

BUILDING NAME	INTERNATIONAL GALLERY
ADDRESS	1100 JEFFERSON DR SW WASHINGTON DC 20004
PROJECT TITLE	QUAD REPLACE TRACK LIGHTING AT INTL GALLERY
SF PROJECT NUMBER	2109103
A/E PROJECT NUMBER	55-23102-00
DRAWING TITLE	REFLECTED CEILING PLAN
DRAWING TYPE	RCP
DESIGNED BY	
DRAWN BY	
CHECKED BY	
A-101	A RCP 101
DISCIPLINE	TYPE SEQUENCE